


Site Layout - Key Plan
Scale: 1:5000

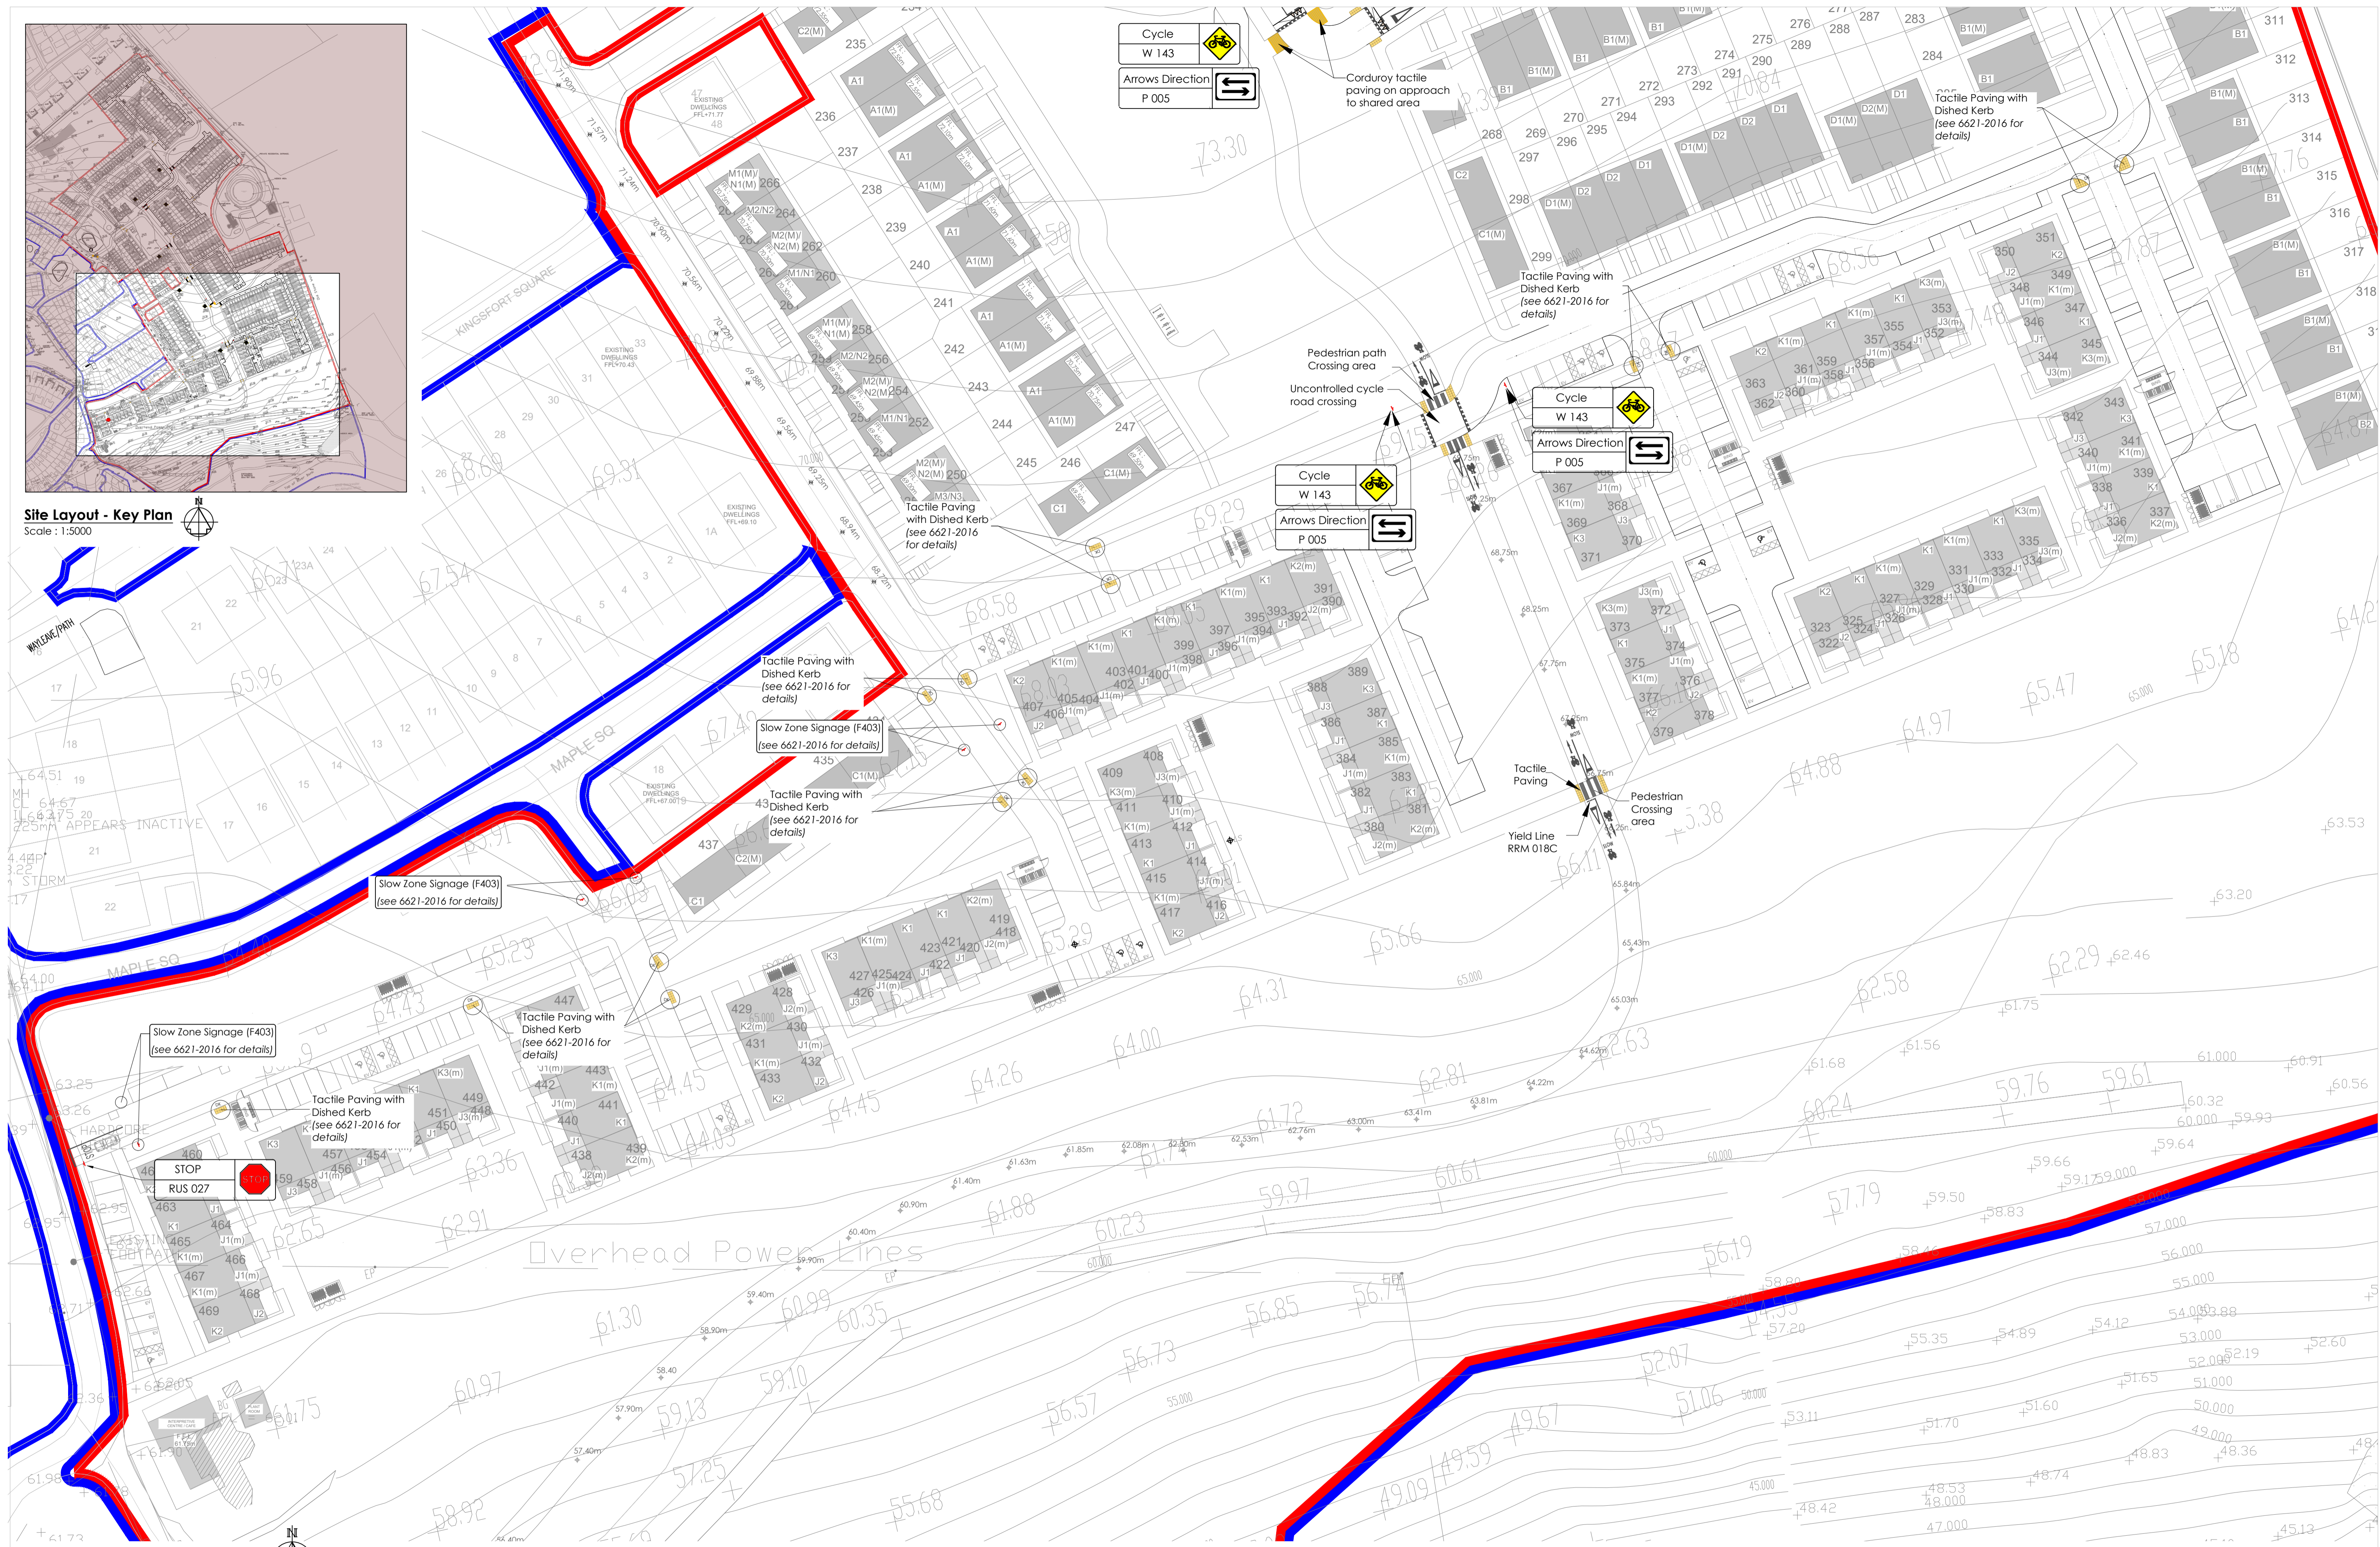

Proposed Drainage Layout 3 of 3
Scale: 1:500

REV.	DRAWN	CHKD	APPRVD	DATE	DETAILS
B	K.M.	S.O.G.	S.O.G.	01.10.24	Issued for LRD Application
A	K.M.	S.O.G.	S.O.G.	27.09.24	Issued for LRD Application