


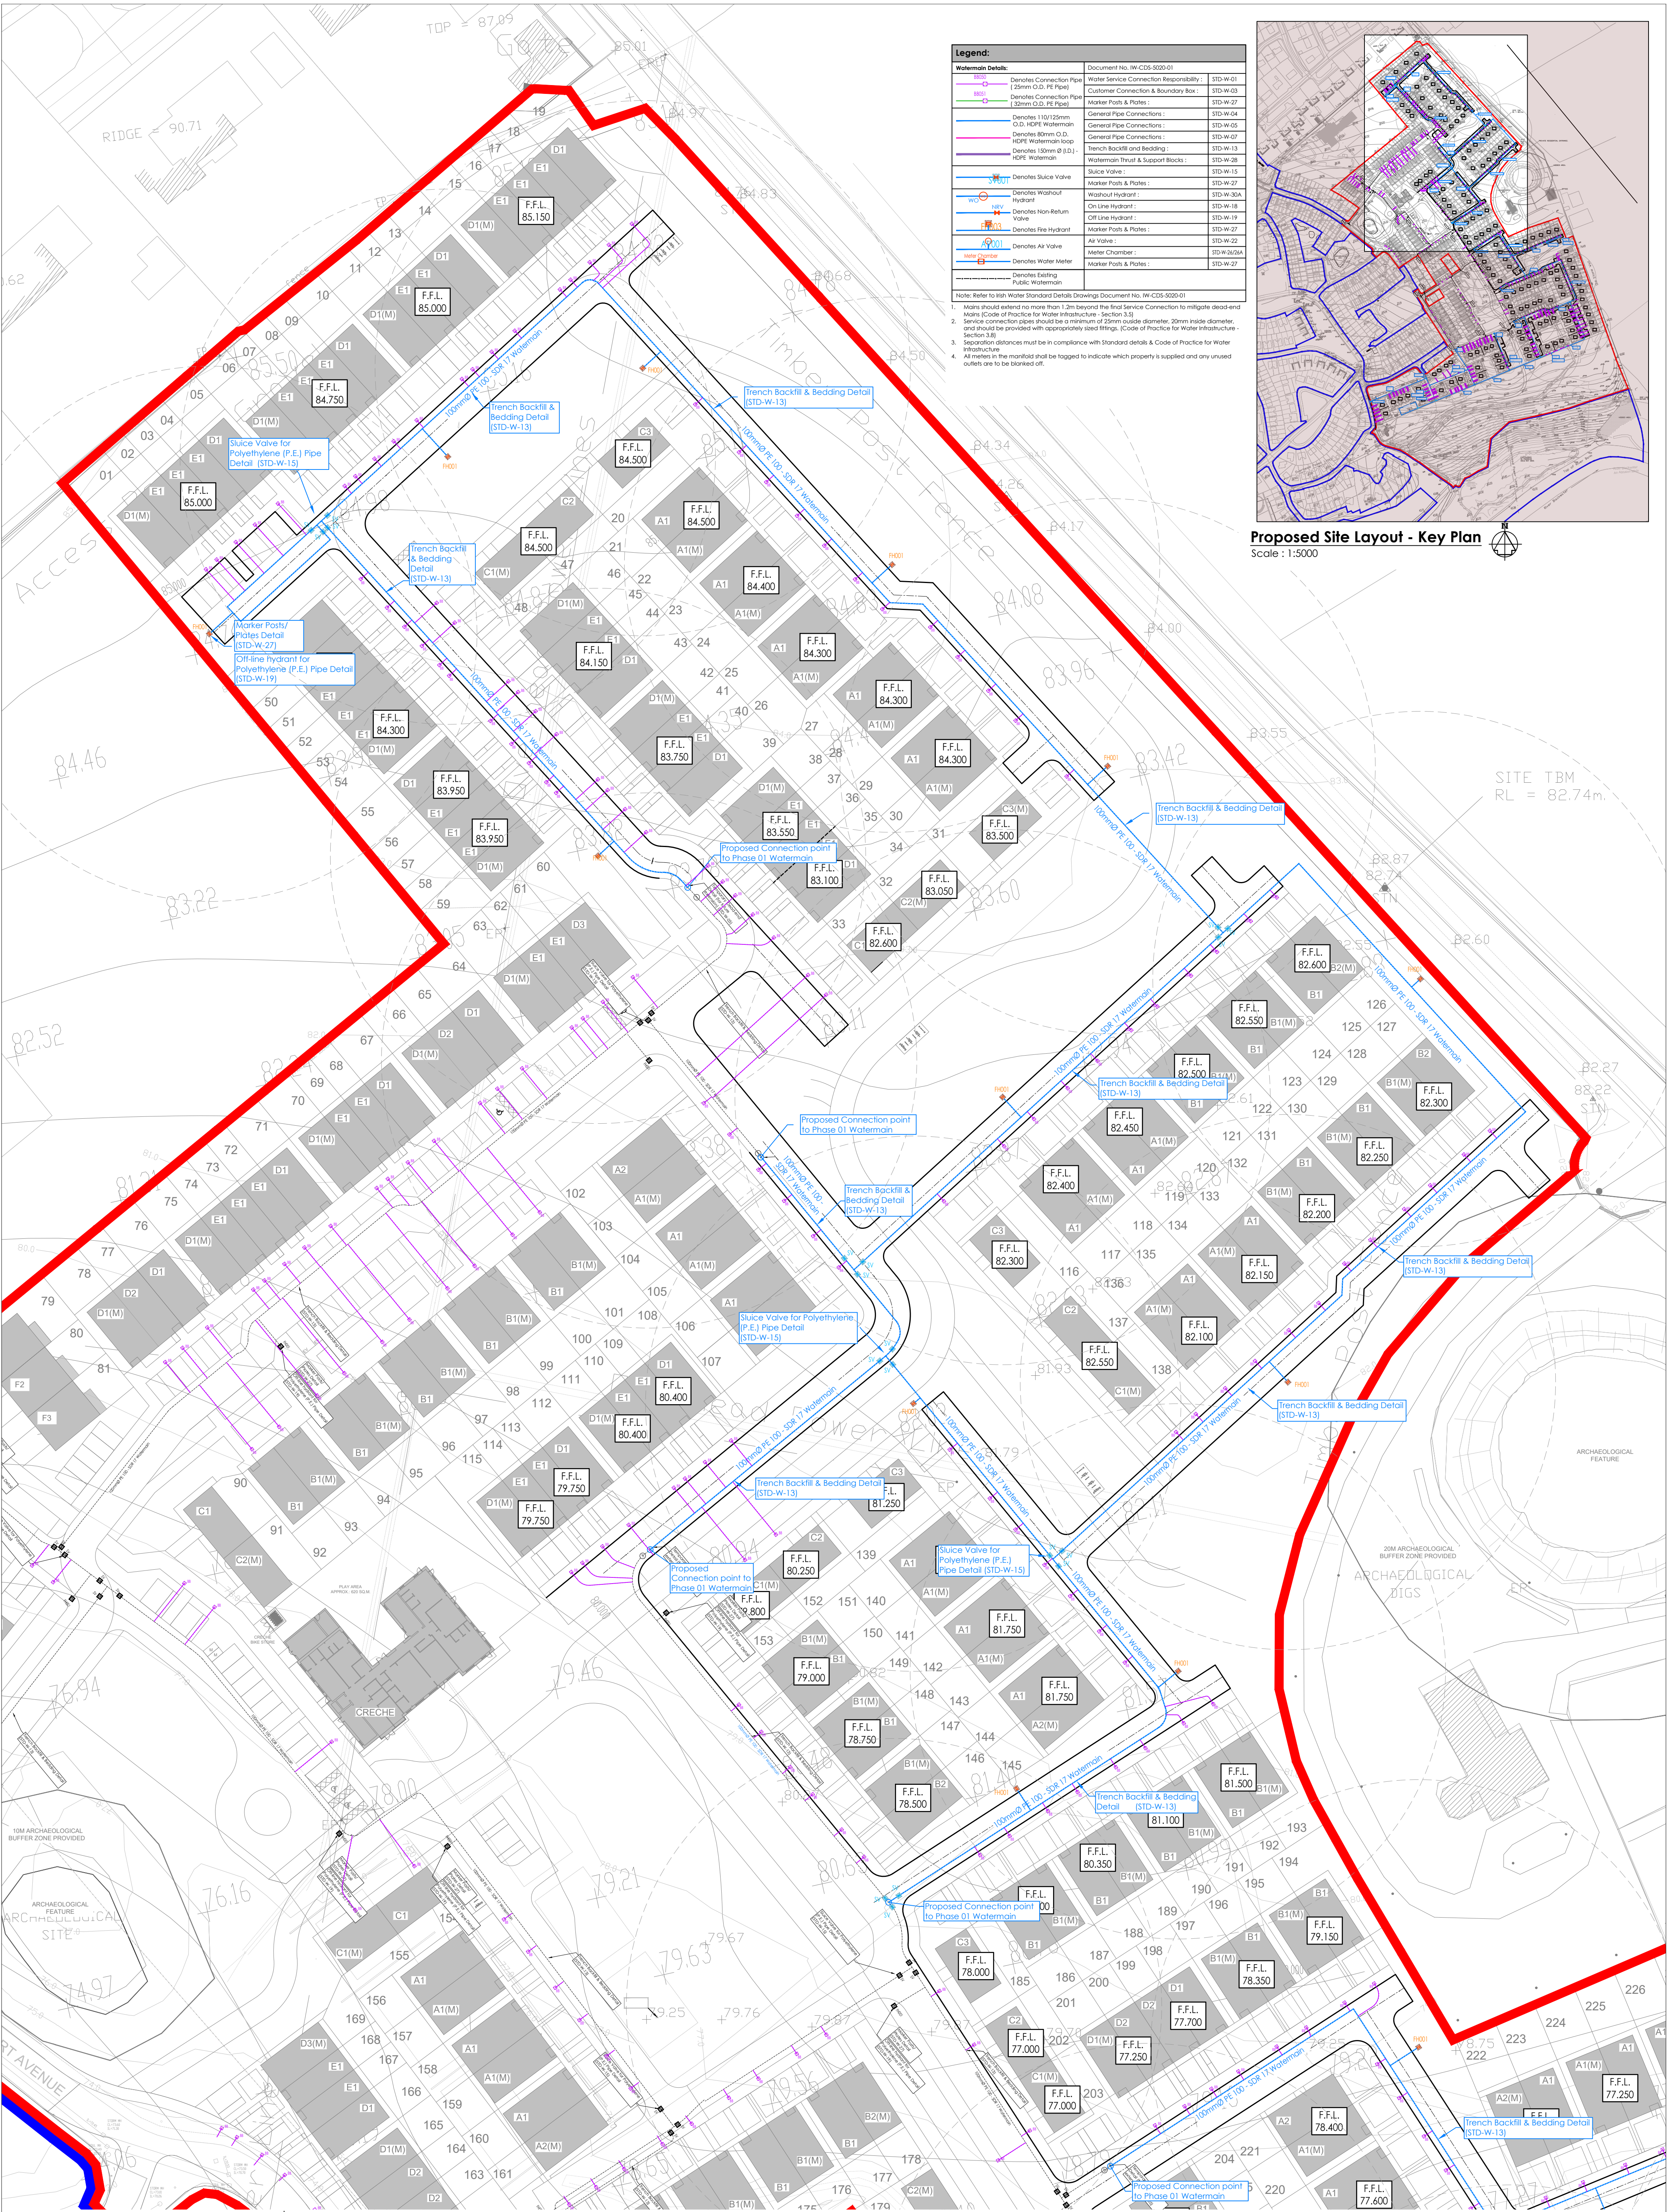

Proposed Watermain Layout 1 of 3
Scale: 1:5000

DOSA
DENIS O'SULLIVAN & ASSOCIATES
CONSULTING ENGINEERS

Joyce House
Barack Square
Bollinacilly
Cork
P31 KP84

021 4871781
info@dosa.ie
www.dosa.ie

© THIS DRAWING IS COPYRIGHT.
NO PART OF THE DOCUMENT
MAY BE REPRODUCED OR
TRANSMITTED IN ANY FORM OR
STORED IN ANY RETRIEVAL
SYSTEM OR ANY NATURE WITHOUT
THE WRITTEN PERMISSION OF THE
ENGINEER AS COPYRIGHT
HOLDER EXCEPT AS AGREED FOR
USE ON THE PROJECT FOR WHICH
THE DOCUMENT WAS
ORIGINALLY ISSUED.

REV.	DRAWN	CHKD	APPRVD	DATE	DETAILS
D	K.M.	S.O'G	S.O'G	16.10.24	Issued for LRD Application

CLIENT	Reside (Castlepark) Ltd.
PROJECT	Castlepark, Mallow, Co. Cork

DRAWING TITLE	Proposed Drainage Layout 1 of 3
SHEET	A1
SCALE	1:500
PROJECT NO.	6621
DRAWING NO.	2030
STATUS/ISSUE	D